


Diagram 1

LEGEND

- ☆ MAIN FRONT ENTRANCE
- ☐ BUS LOADING
- ↔ BUILDING EGRESS
- ↔ CLASSROOM EXIT
- ☐ SECURITY PAD
- ⚡ MAIN ELECTRIC SHUTOFF
- ☎ MAIN TELEPHONE/ DATA SHUTOFF
- ☐ MAIN NATURAL GAS SHUTOFF
- ☒ MAIN WATER SHUTOFF
- ☒ MAIN SPRINKLER FLOW SHUTOFF

ABBREVIATIONS

- CONF CONFERENCE
- ELC ELECTRICAL CLOSET
- HTC HANITORY CLOSET
- JAN JANITORS CLOSET
- MEC MECHANICAL CLOSET
- OFF OFFICE
- ACC ACCESS
- ROOF ROOF ACCESS
- TOILET TOILET
- TL TEACHER'S LOUNGE

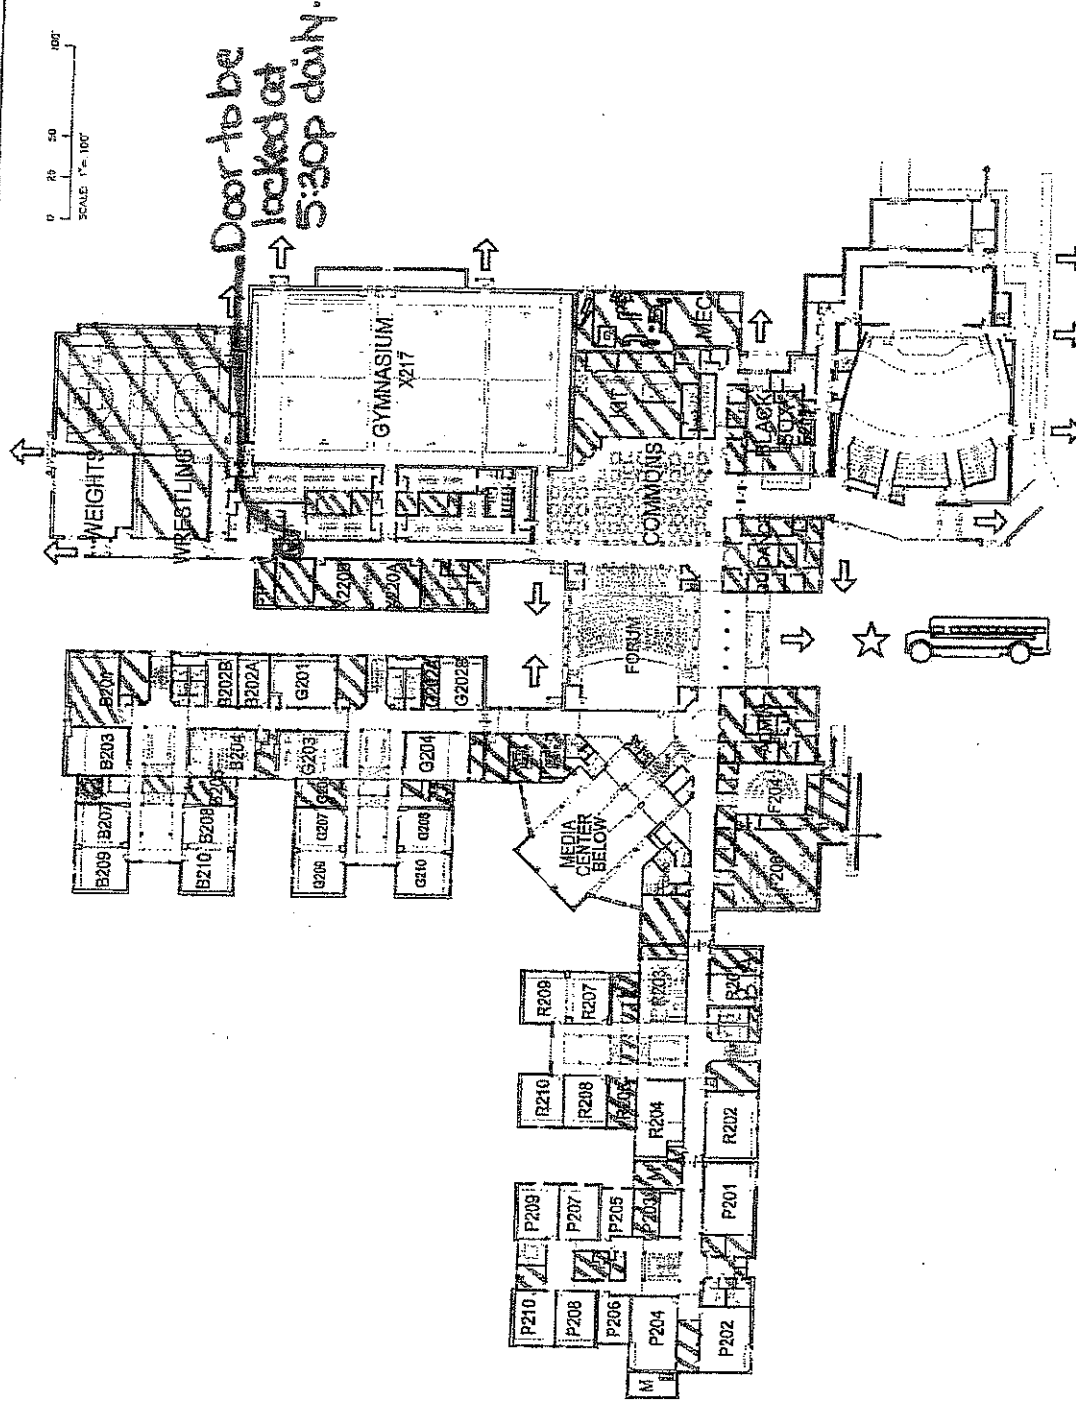

MONTICELLO HIGH SCHOOL
SECOND FLOOR PLAN
ALBEMARLE COUNTY SCHOOLS
REV. OCTOBER 2006

Upper

Diagram 1 continued


LEGEND

- ☆ MAIN FRONT ENTRANCE
- ☐ BUS LOADING
- ↔ BUILDING EGRESS
- ← CLASSROOM EXIT
- ☐ SECURITY PAD
- ⚡ MAIN ELECTRIC SHUTOFF
- ☎ MAIN TELEPHONE/ DATA SHUTOFF
- ☐ MAIN NATURAL GAS SHUTOFF
- ☐ MAIN WATER SHUTOFF
- ☐ MAIN SPRINKLER FLOW SHUTOFF

ABBREVIATIONS

- CNF CONFERENCE
- E.C. ELECTRICAL CLOSET
- H.C. HANDICAPPED TOILET
- M.C. MECHANICAL CLOSET
- M.C. MECHANICAL CLOSET
- OFF OFFICE
- RA ROOF ACCESS
- ST STORAGE
- TL TOILET
- TL TEACHERS LOUNGE

0 25 50 100
SCALE: 1" = 100'

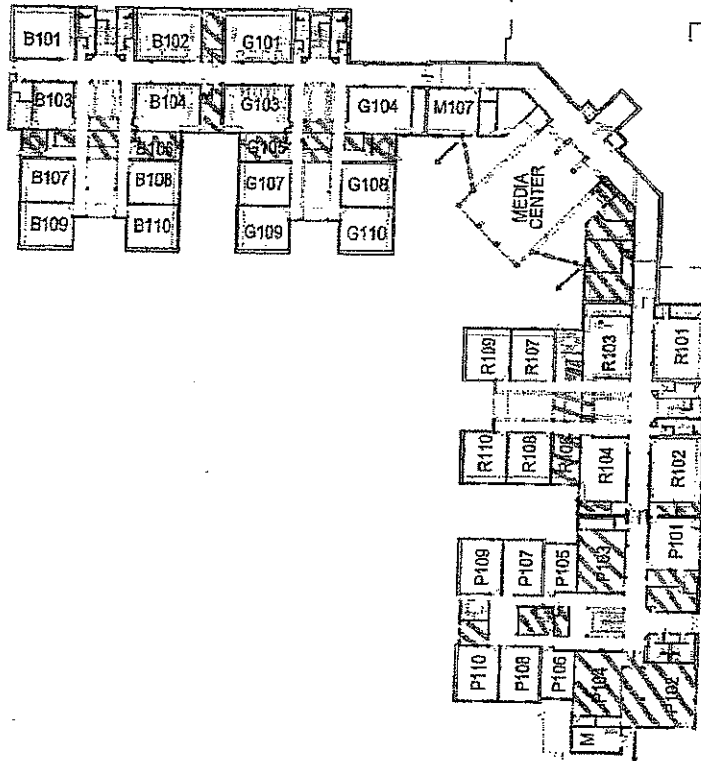


MONTICELLO HIGH SCHOOL
SECOND FLOOR PLAN
ALBEMARLE COUNTY SCHOOLS
REV. OCTOBER 2006
Lower

Diagram 2

LEGEND: LOCATIONS OF UTILITY LINES ARE APPROXIMATE



 MAIN FRONT ENTRANCE



FH



SM



TELEPHONE/ POWER POLE

E

BELOW GRADE ELECTRICAL LINE

EE

ABOVE GRADE ELECTRICAL LINE

T

BELOW GRADE TELEPHONE LINE

TT

ABOVE GRADE TELEPHONE LINE

FO

UNDERGROUND FIBER OPTIC LINE

W

BELOW GRADE WATER LINE

S

BELOW GRADE SANITARY SEWER

SS

BELOW GRADE STORM SEWER

G

BELOW GRADE GAS LINE

UST

UNDERGROUND STORAGE TANK

WL

WELL/ WELL HOUSE

SP

SEWAGE PLANT

TRL

CLASSROOM TRAILER

PH

PUMP HOUSE

UM

UTILITY MANHOLE

WM

WATER METER

GI


GREASE INTERCEPTOR

AFT

ABOVE GROUND FUEL TANK

CWT

CHEMICAL WASTE INTERCEPTOR

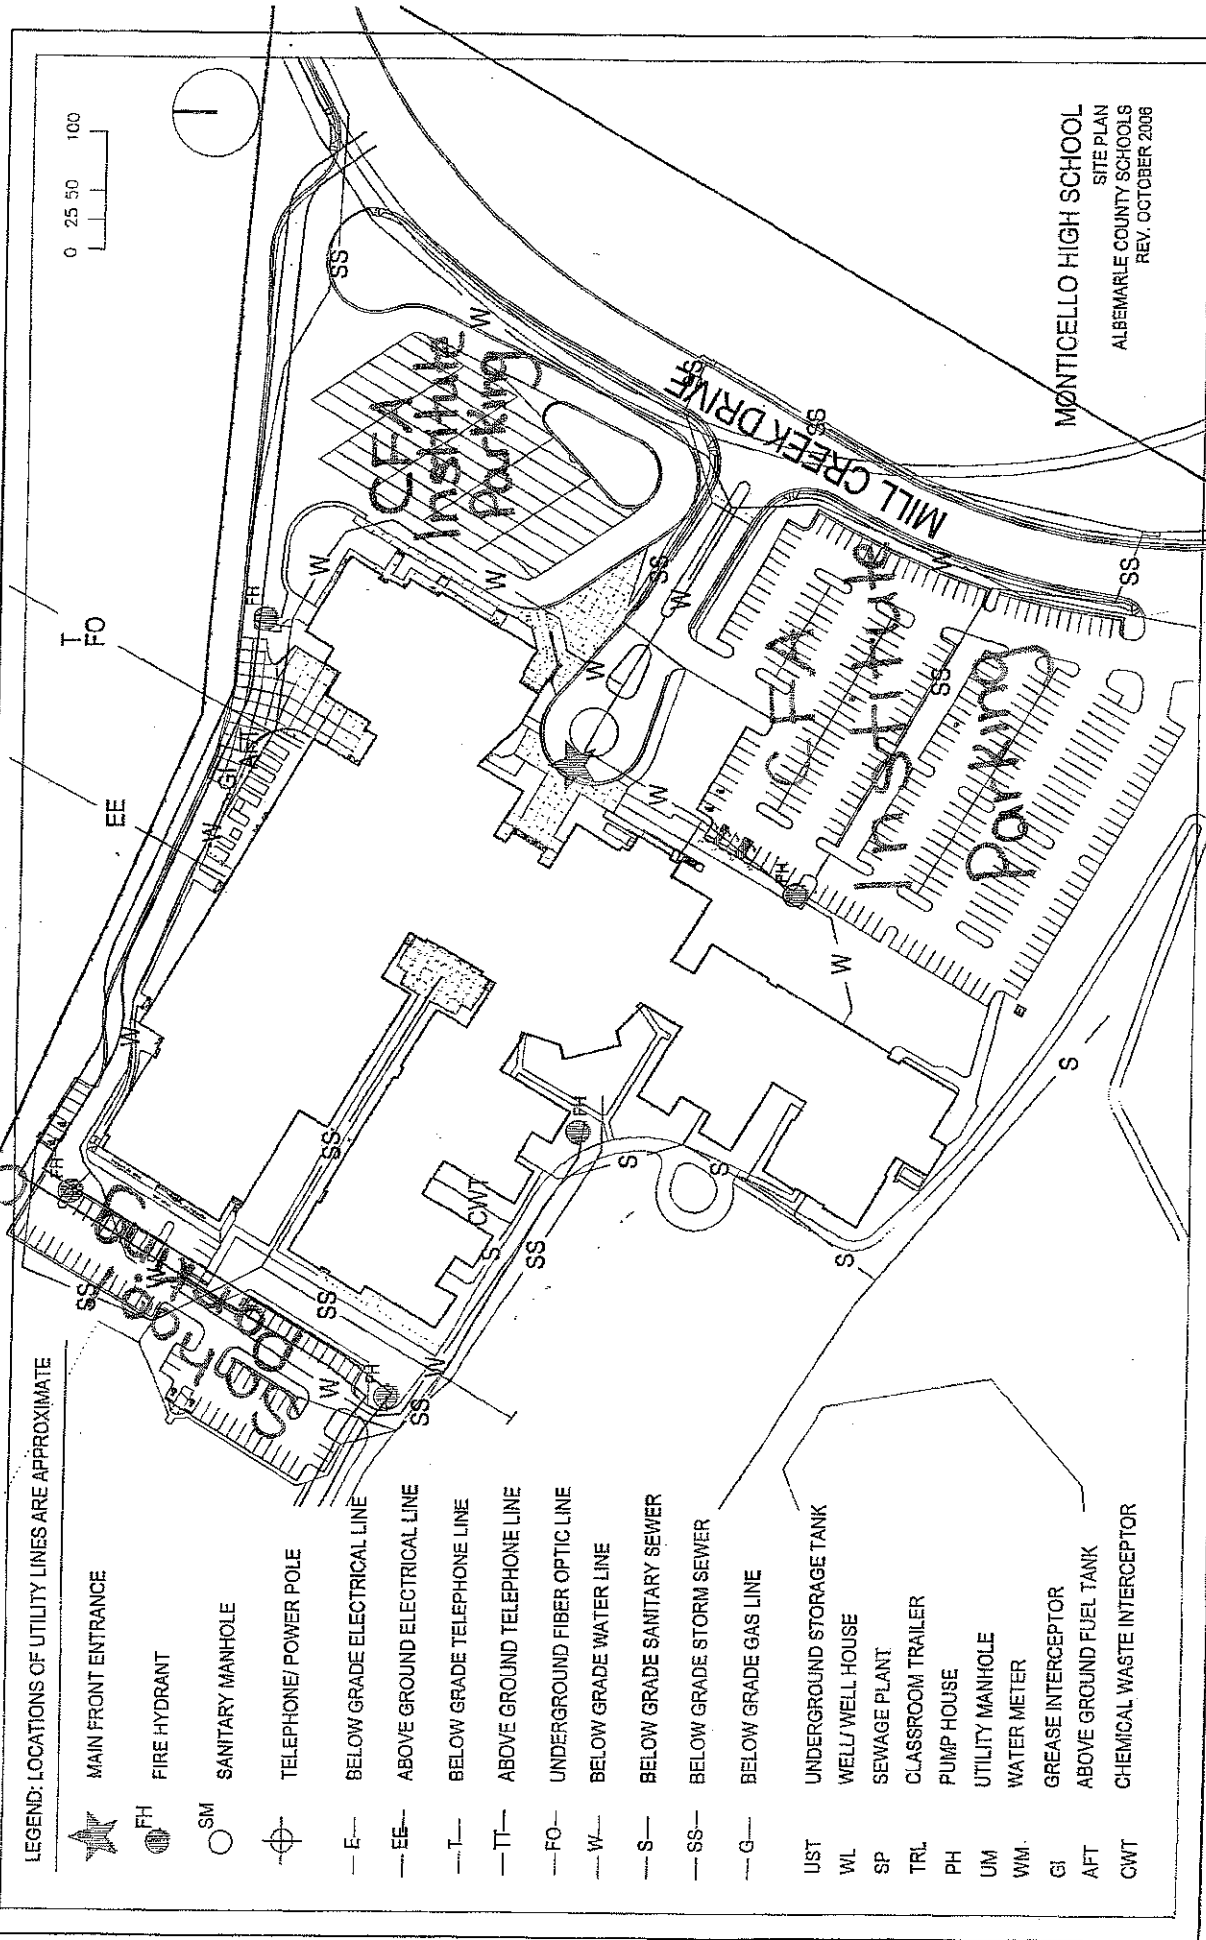

MONTICELLO HIGH SCHOOL
SITE PLAN
ALBEMARLE COUNTY SCHOOLS
REV. OCTOBER 2006

CFA Institute Parking
also next to baseball
field.