


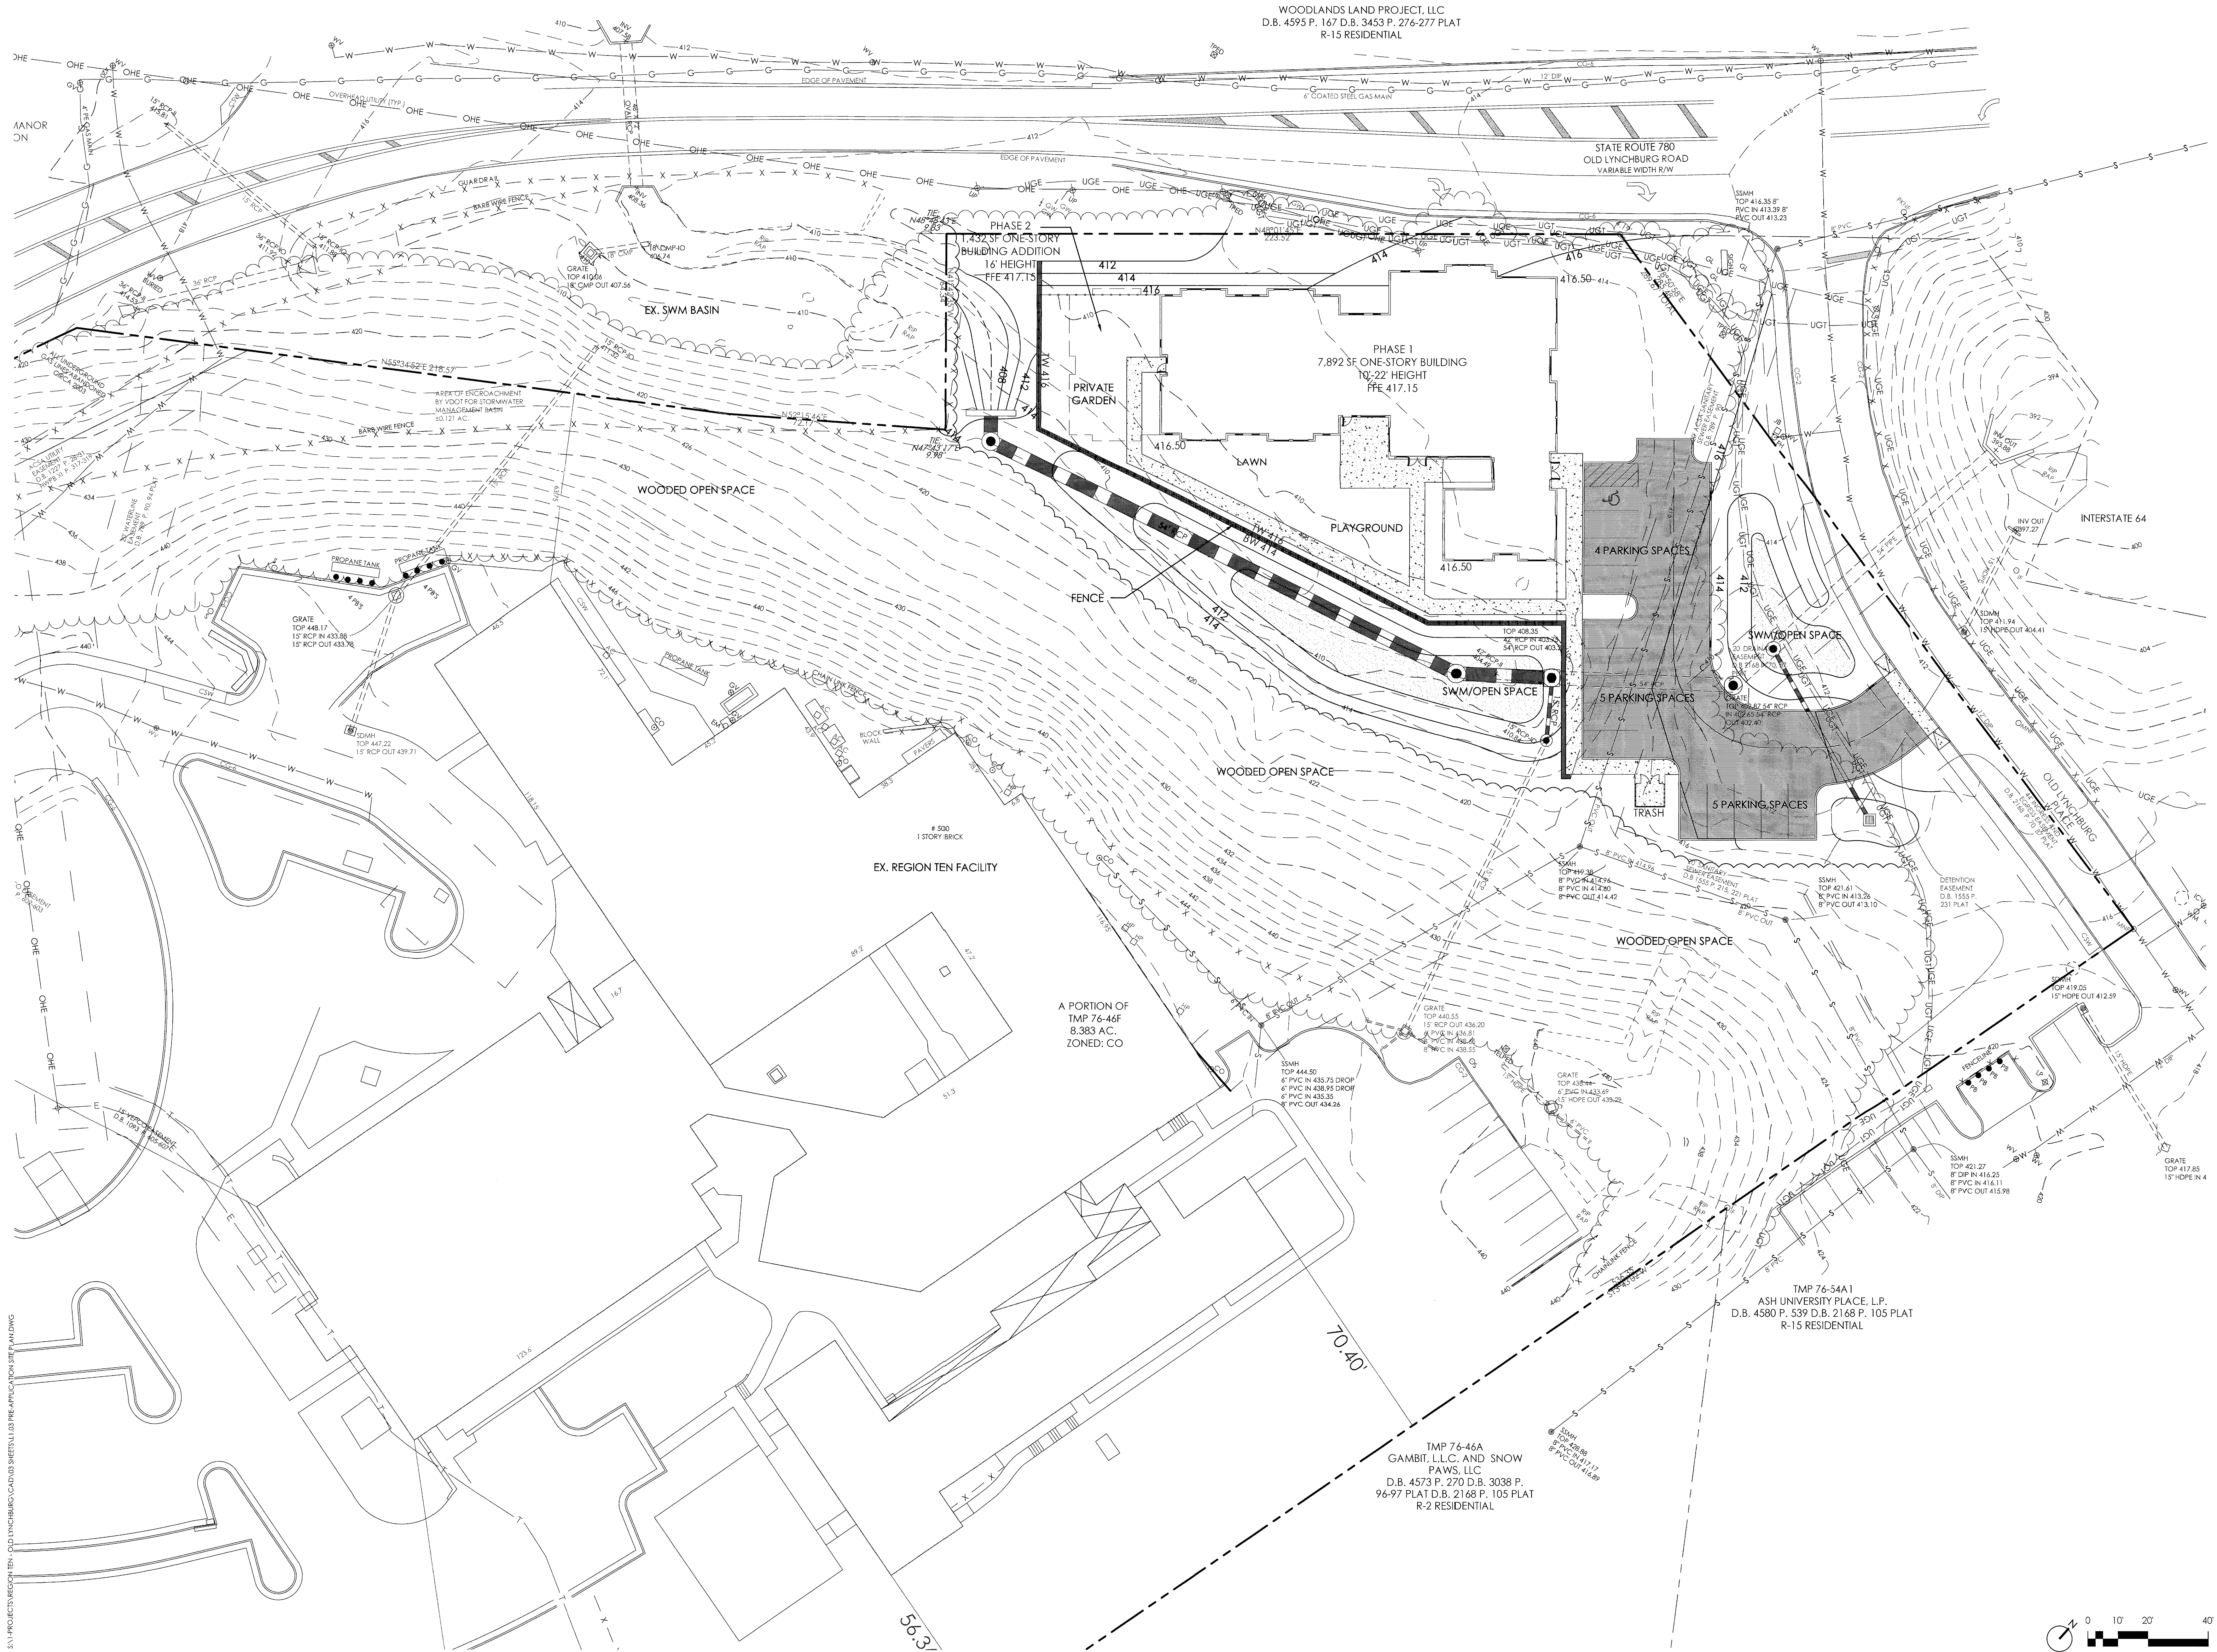

professional seal
ALAN FRANKLIN, PE
project manager
JESSE CALDER
project team

REGION TEN
WOMEN'S SHELTER
project name
REGION 10 COMMUNITY
SERVICES BD, INC.
client
502 OLD LYNCHBURG ROAD
CHARLOTTESVILLE, VIRGINIA 22903
project address

NA
project number

COMPREHENSIVE PLAN COMPL.
project phase

JUNE 20, 2016
issue date

revisions

SITE PLAN
sheet title

L1.03
sheet number